

SYMBOL LIST	
[BA]	BURGLAR ALARM PANEL
[KP]	KEYPAD - CAN BE FIELD LOCATED
[ES]	ELECTRIC STRIKE
[R]	CARD READER
[R/P]	CARD READER WITH PIN PAD
[M]	MOTION DETECTOR
[R]	REQUEST TO EXIT
[M]	MOTION DETECTOR
[PB]	PUSH BUTTON
[D]	DURESS ALARM (WALL MOUNTED)
[R]	REQUEST TO EXIT
[E]	EMERGENCY DOOR RELEASE
[I]	INTERCOM (TELEPHONE ENTRY)
[E2]	EMERGENCY CALL UNIT
[C2]	PTZ DOME CAMERA
[C]	CAMERA WITH FIXED LENS
[ML]	MAGNETIC LOCK
[C]	MAGNETIC CONTACT
[M]	COLOR MONITOR
[P]	PIR
[R2]	15 SECOND EMERGENCY EXIT DELAY
[KS]	KEY SWITCH
[H]	HOLDUP ALARM LIGHT
[H]	HOLDUP BUTTON
[BT]	BILL TRAP
[GB]	GLASS BREAK DETECTOR
[F]	FUTURE DEVICE
[P]	PHOTOELECTRIC BEAM
[V1]	REFERENCE NUMBER
[V2]	CAMERA NUMBER
[V3]	SHEET/DETAIL
[V4]	POWER SUPPLY NUMBER
[D]	DOOR NUMBER
[C]	SHEET/DETAIL
[C]	C NUMBER/REARBOARD (BY FLOOR)
[I/O]	INPUT/OUTPUT
[Z]	SHEET/DETAIL
[Z]	ZONE

REFERENCE DRAWINGS		
Dwg. File Name	Title	
REVISIONS		
No.	Date	Description
1	9/22/03	added reader door
2	6/10/04	updated system per(MH)

Stamp Area:


COX
NEWSPAPERS, INC.

North Carolina Publications
The Daily-Advance
Elizabeth City, NC.

tyco Fire & Security **ADT**
ADT Security Services, Inc.
Systems Sales & Engineering
8607 Roberts Dr.
Atlanta, Ga. 30328
678-625-5800

Drawn By: SL Date: 10/23/03
Checked By: * Revision: 6/10/04
DWG. File Name: 2003 DailyAdvance 1st
Sales Consultant: MH
Title: First Floor
CCTV + Access
Device Location Plan
Scale: 3/16"=1'
Sheet: ADT-1

FIRST FLOOR PLAN
3/16" = 1'-0" 7,850 Sq. Ft.
DOES NOT INCLUDE FRONT, REAR, AND DOCK OVERHANGS

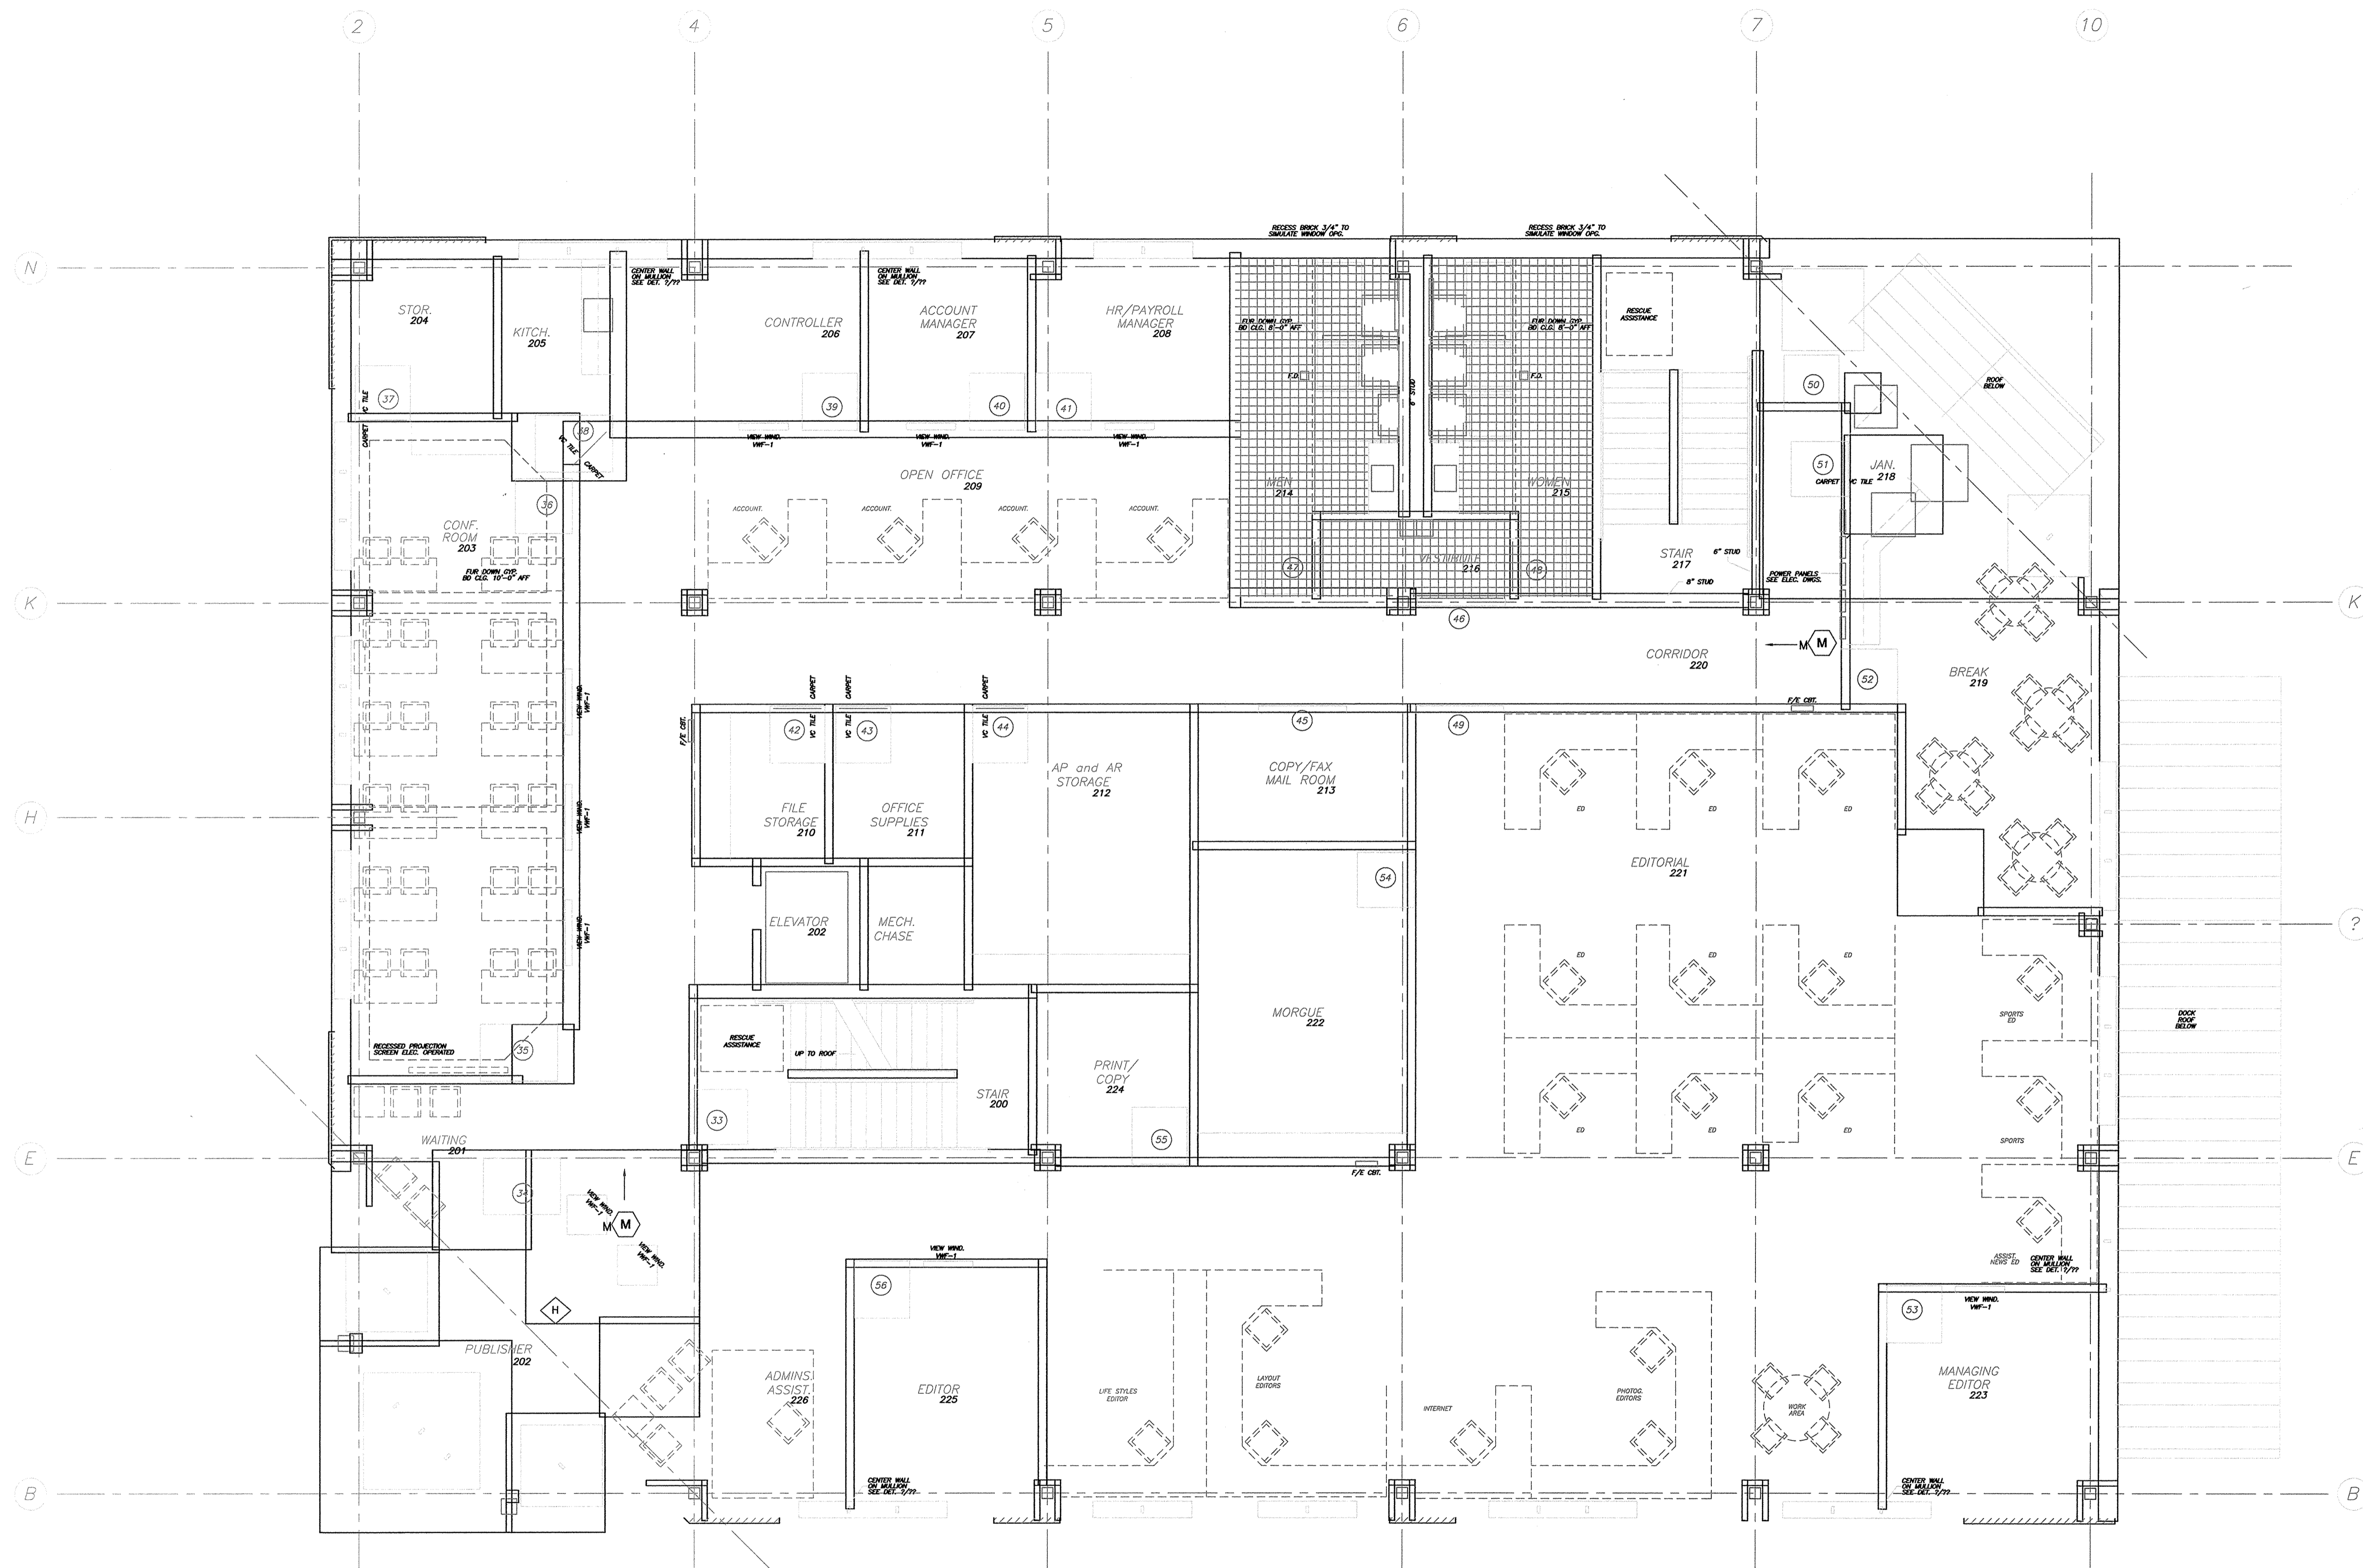

➔ SECOND FLOOR PLAN
3/16" = 1'-0" 8,030 Sq. Ft.

SYMBOL LIST	
BA	BURGLAR ALARM PANEL
KP	KEYPAD - CAN BE FIELD LOCATED
ES	ELECTRIC STRIKE
CA	CARD READER
CP	CARD READER WITH PIN PAD
MD	MOTION DETECTOR
R	REQUEST TO EXIT
M	MOTION DETECTOR
DB	PUSH BUTTON
D	DURESS ALARM (WALL MOUNTED)
R	REQUEST TO EXIT
E	EMERGENCY DOOR RELEASE
INT	INTERCOM (TELEPHONE ENTRY)
ECU	EMERGENCY CALL UNIT
PTZ	PTZ DOME CAMERA
CM	CAMERA WITH FIXED LENS
ML	MAGNETIC LOCK
C	MAGNETIC CONTACT
M	COLOR MONITOR
PIR	PIR
15	15 SECOND EMERGENCY EXIT DELAY
KS	KEY SWITCH
HL	HOLDUP ALARM LIGHT
DB	HOLDUP BUTTON
BT	BILL TRAP
GB	GLASS BREAK DETECTOR
F	FUTURE DEVICE
PB	PHOTOELECTRIC BEAM
REF	REFERENCE NUMBER
1	CAMERA NUMBER
S/S/CS	SHEET/DETAIL
11000	POWER SUPPLY NUMBER
D	DOOR NUMBER
IC	IC NUMBER/READERBOARD (BY FLOOR)
I/O	INPUT/OUTPUT
S/D	SHEET/DETAIL
Z	ZONE

REFERENCE DRAWINGS		
Dwg. File Name	Title	
*	*	
REVISIONS		
No.	Date	Description
1	9/22/03	added reader door

Stamp Area:

COX
NEWSPAPERS, INC.

North Carolina Publications
The Daily Advance
Elizabeth City, NC.

tyco Fire & Security **ADT**

ADT Security Services, Inc.
Systems Sales & Engineering

8607 Roberts Dr.
Atlanta, Ga. 30328
678-525-5800

Drawn By:	SL	Date:	10/23/03
Checked By:	*	Revision:	*
DWG. File Name:	Cox DailyAdvance 2nd		
Sales Consultant:	MH		
Title:	Second Floor CCTV + Access Device Location Plan		
Scale:	3/16"=1'		
Sheet:	ADT-2		